

Floor Plan
Scale: 1/8" = 1'

General Notes

No.	Revision/Issue	Date


Firm Name and Address

423 Bowling Gap Circle
Blairsville, Georgia 30512
706-835-1458
www.winklerandwinkler.com

Project Name and Address


Sears Hometown Store
Blairsville, Georgia

Project	Sheet
Date	AI
Scale	

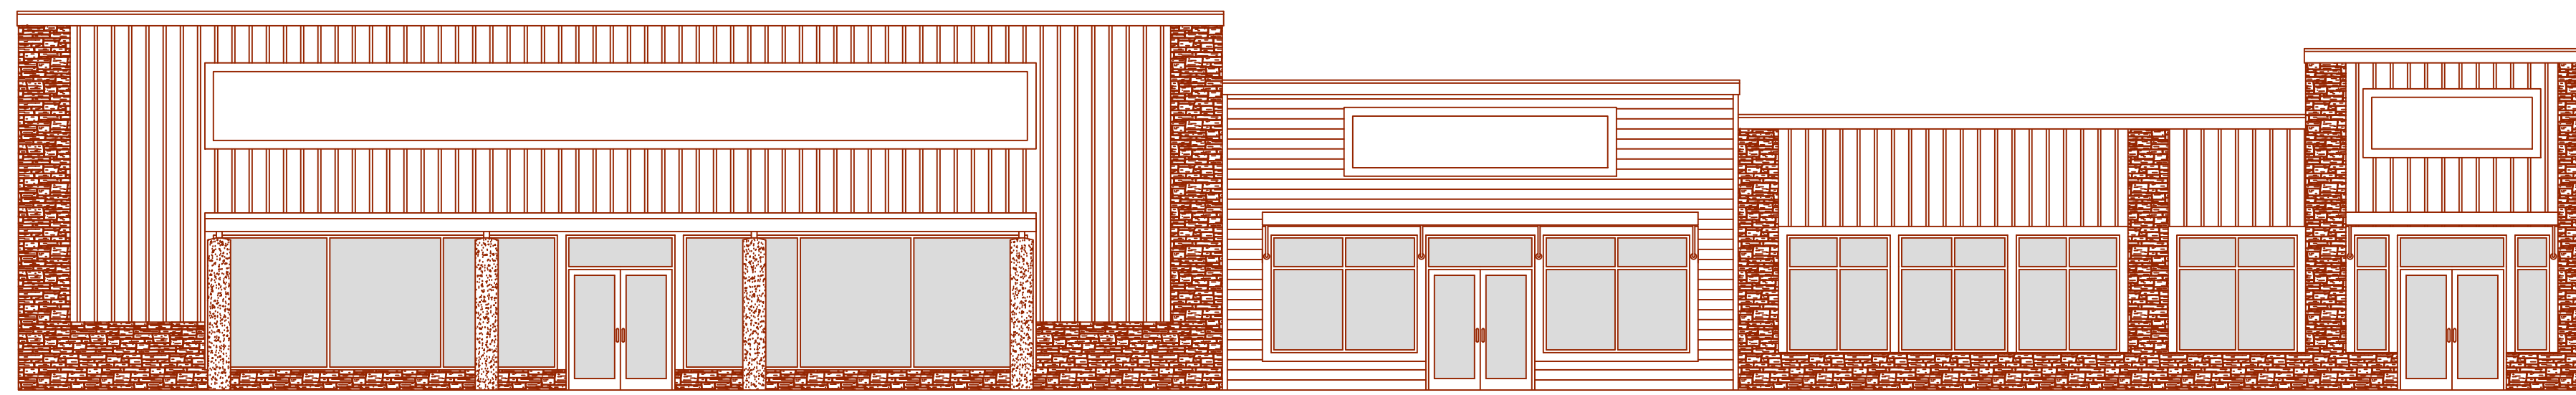


Front Elevation


Roof Pitch: $\frac{1}{2}":12"$

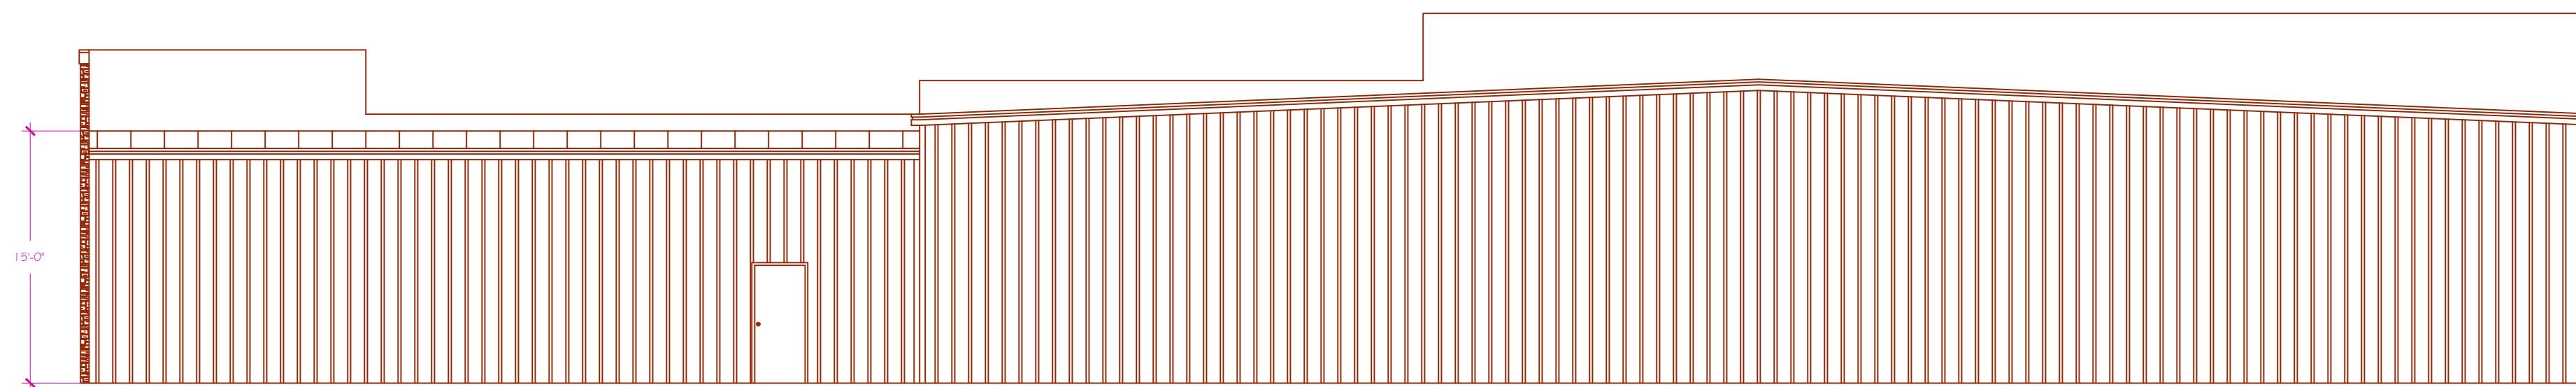

Rear Elevation

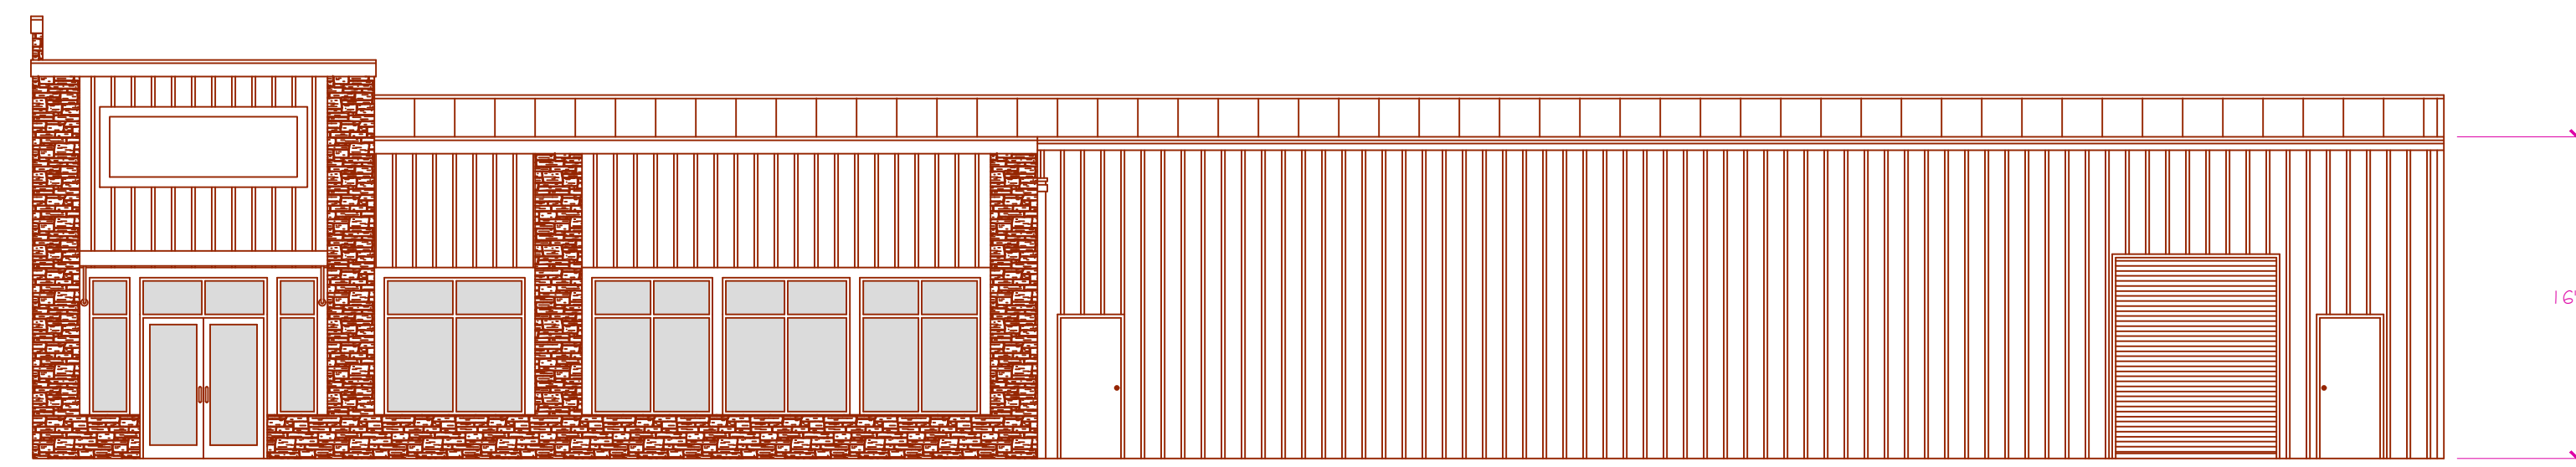

Right Side Elevation

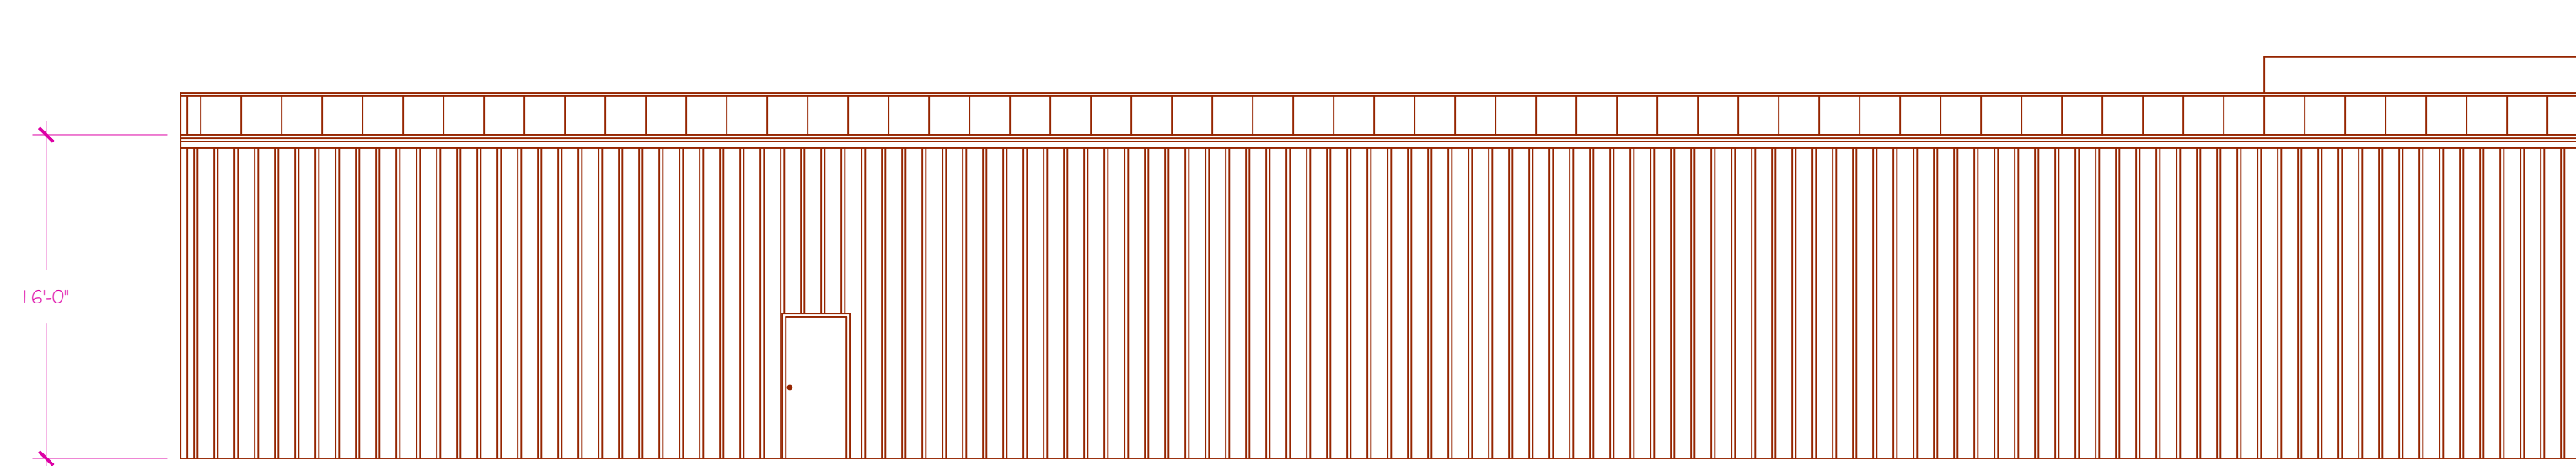

Left Side Elevation

General Notes

No.	Revision/Issue	Date

Firm Name and Address

423 Bowling Gap Circle
Blairsville, Georgia 30512
706-835-1458
www.winklerandwinkler.com

Project Name and Address


Sears Hometown Store
Blairsville, Georgia

Project	Sheet
Date	A3
Scale	

FNAME

REVDATE

USER

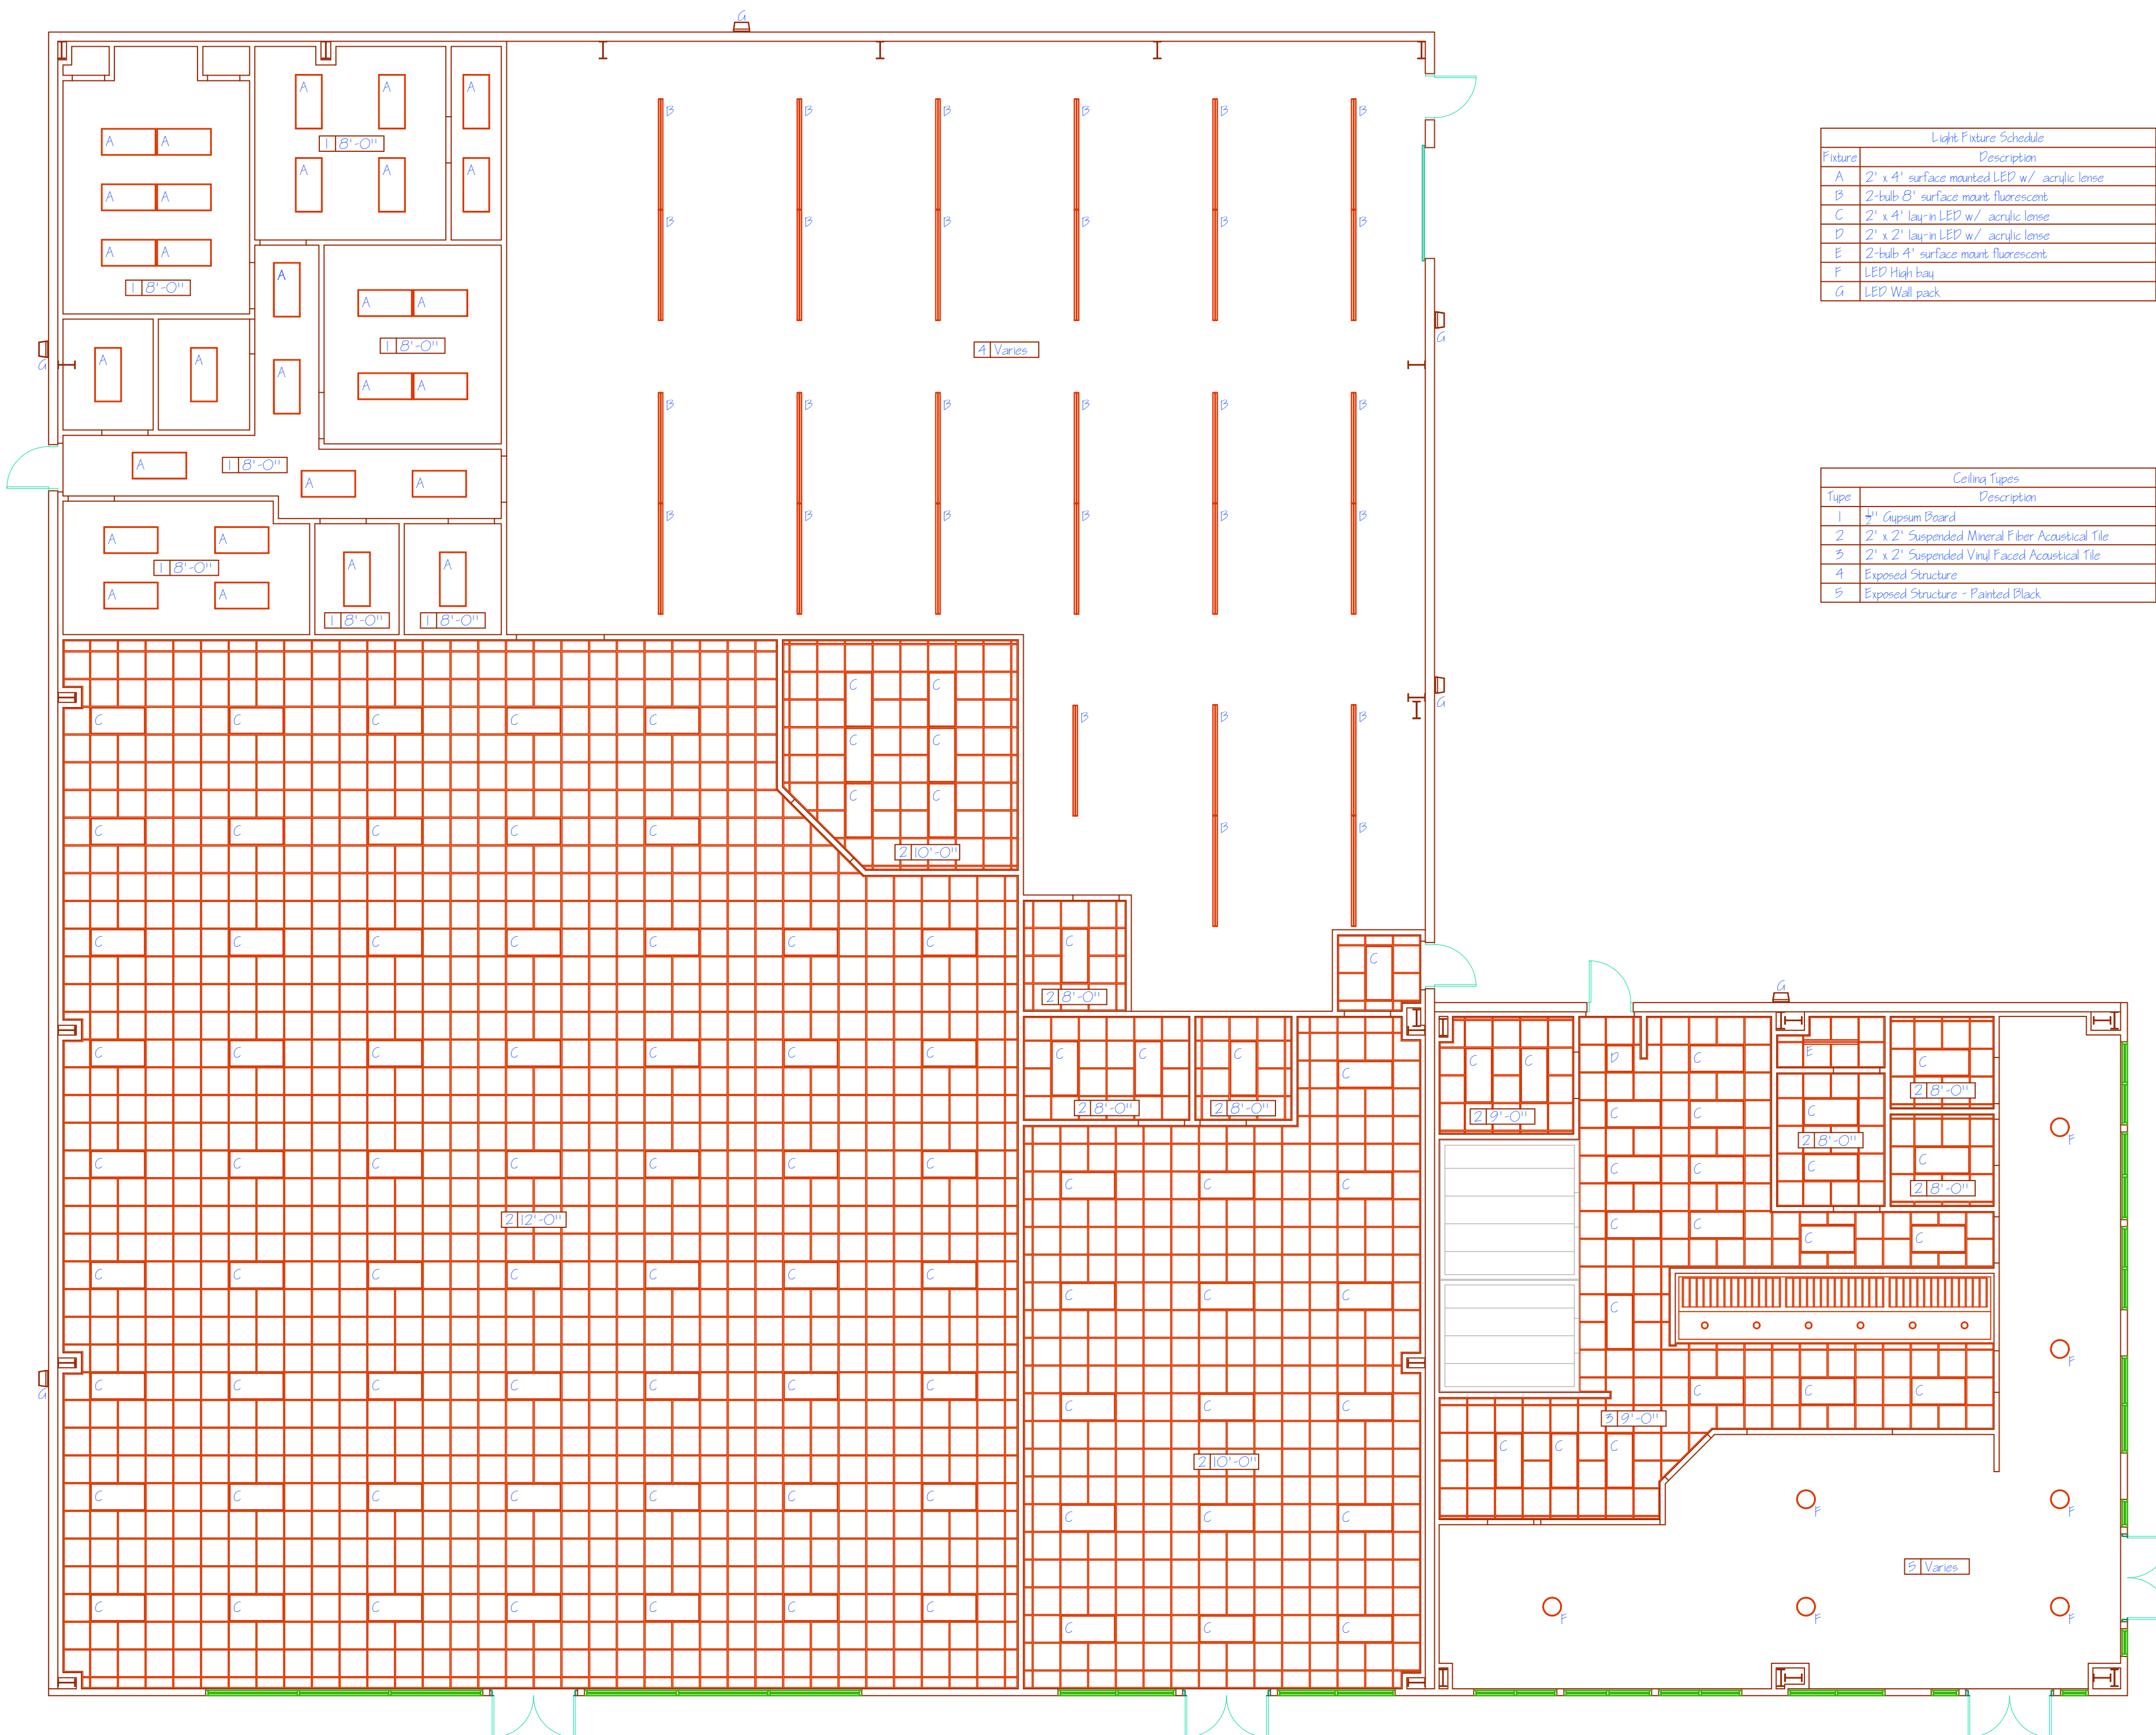

Light Fixture Schedule	
Fixture	Description
A	2' x 4' surface mounted LED w/ acrylic lens
B	2-bulb 6' surface mount fluorescent
C	2' x 4' lay-in LED w/ acrylic lens
D	2' x 2' lay-in LED w/ acrylic lens
E	2-bulb 4' surface mount fluorescent
F	LED High Bay
G	LED Wall pack

Ceiling Types	
Type	Description
1	4" Gypsum Board
2	2' x 2' Suspended Mineral Fiber Acoustical Tile
3	2' x 2' Suspended Vinyl Faced Acoustical Tile
4	Exposed Structure
5	Exposed Structure - Painted Black

Reflected Ceiling Plan
Scale: 1/8" = 1'

General Notes

No.	Revision/Issue	Date

Firm Name and Address

423 Bowling Gap Circle
Blairsville, Georgia 30512
706-835-1458
www.winklerandwinkler.com

Project Name and Address


Sears Hometown Store
Blairsville, Georgia

Project	Sheet
Date	A4
Scale	


FNAME

REVDATE


USER

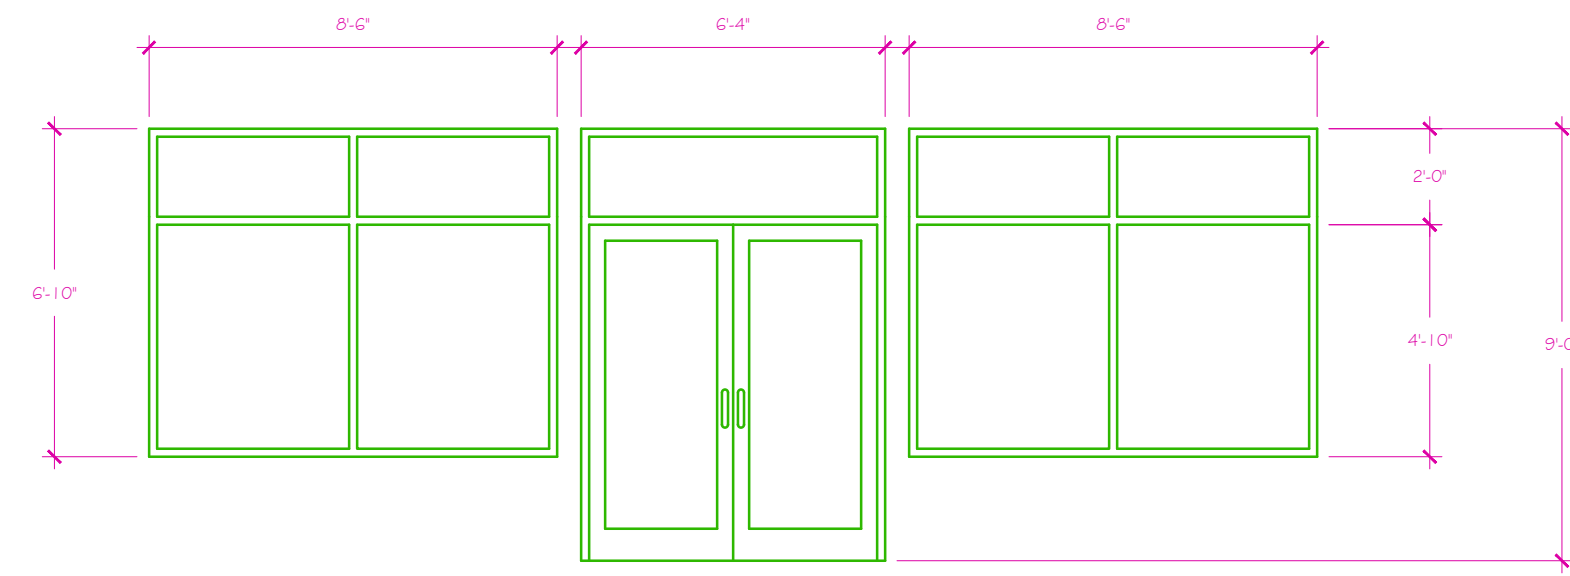


Rental Suite Windows

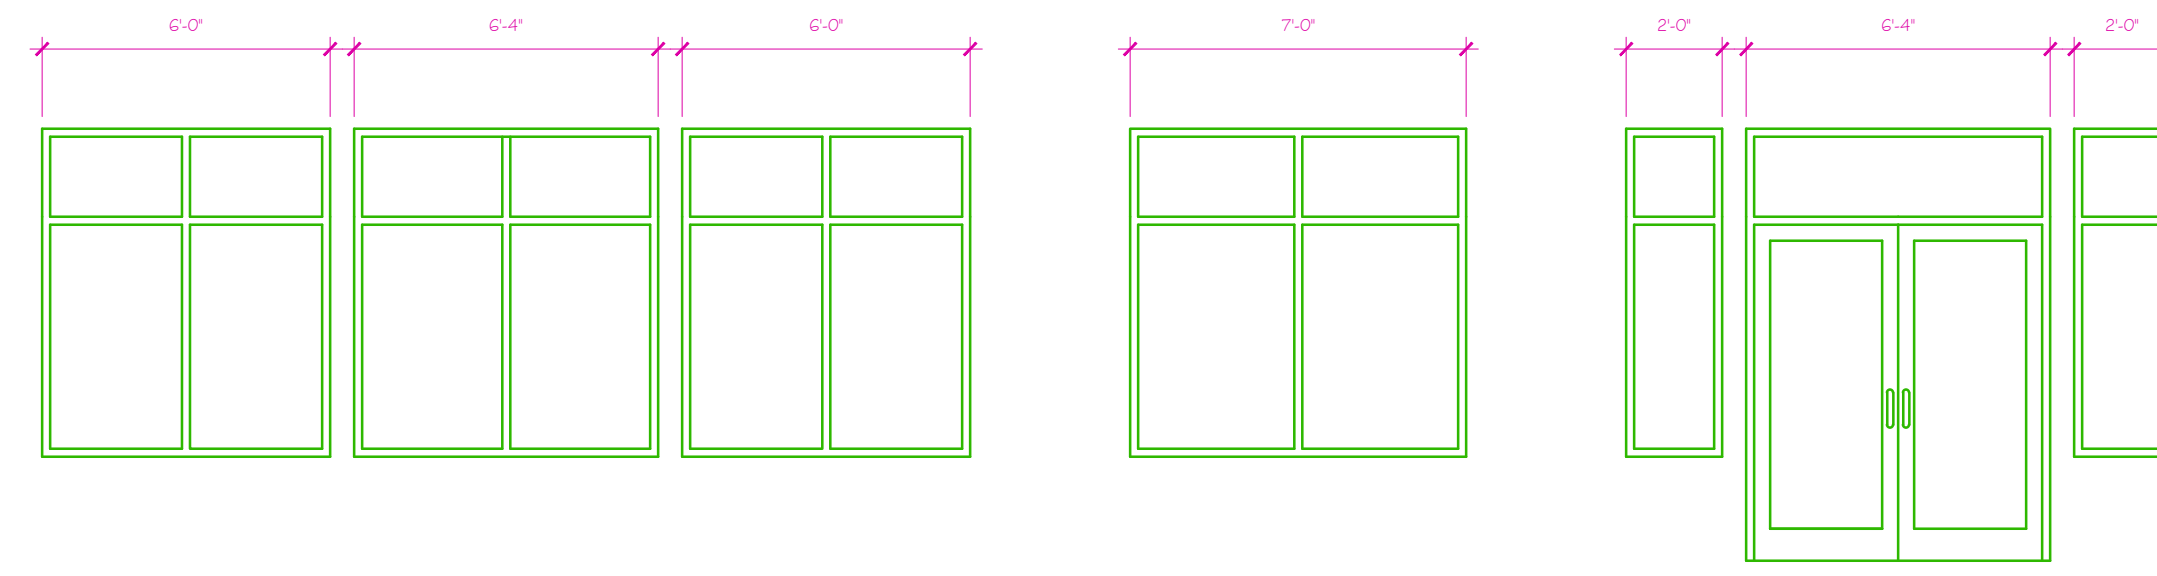


Restaurant Suite Windows (same on front and side)

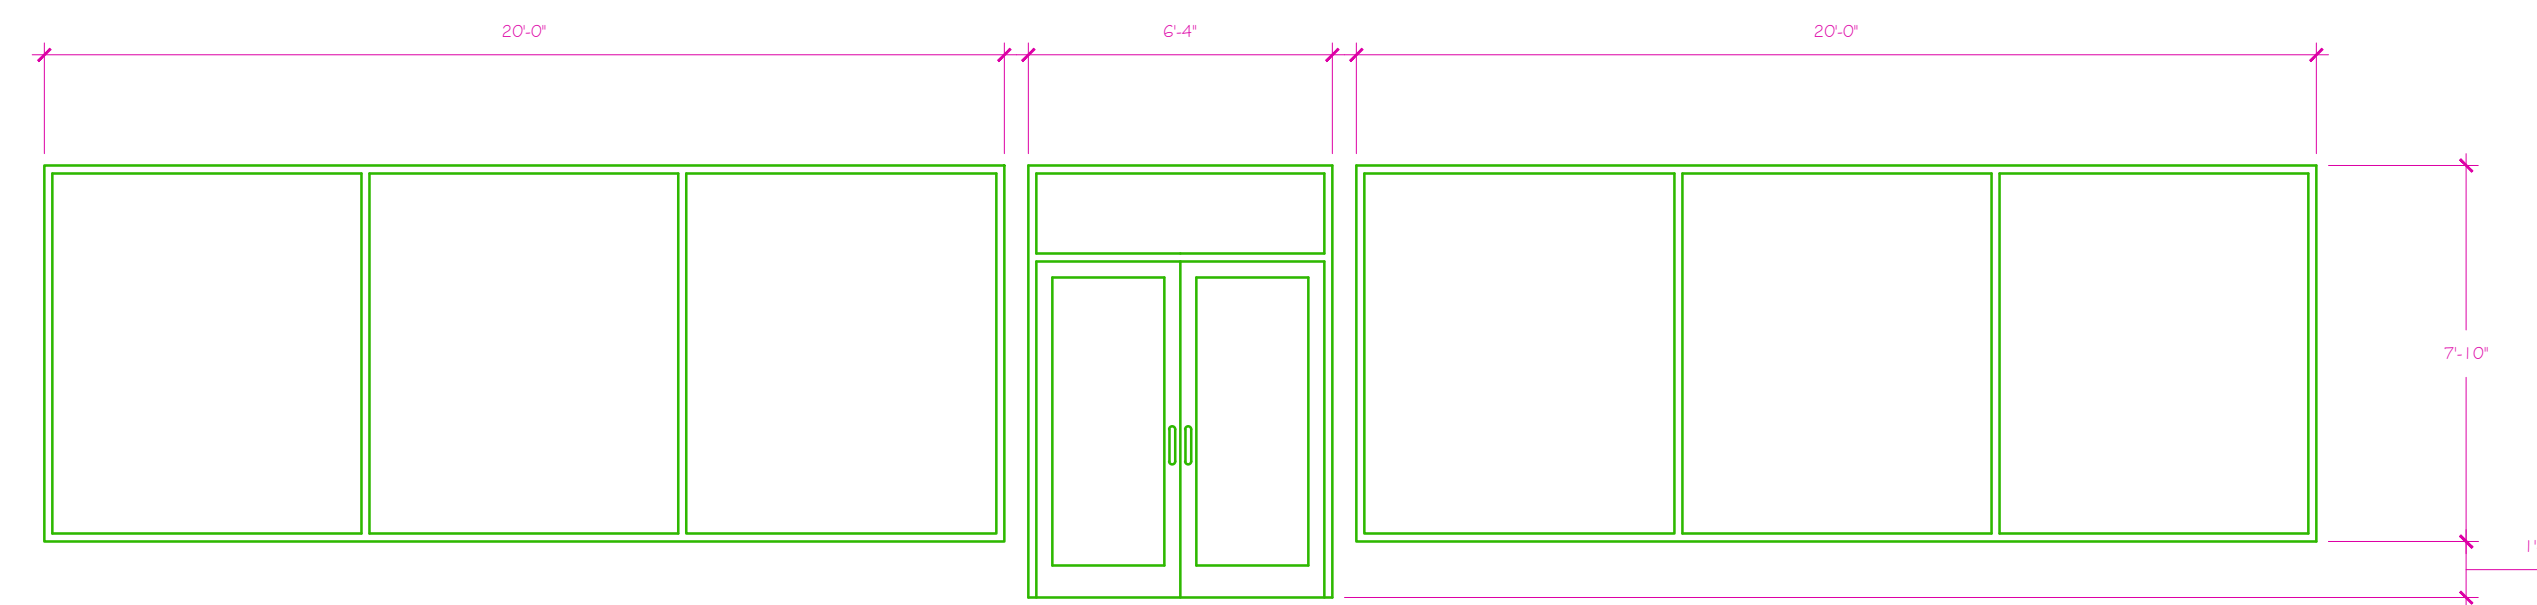

Sears Windows

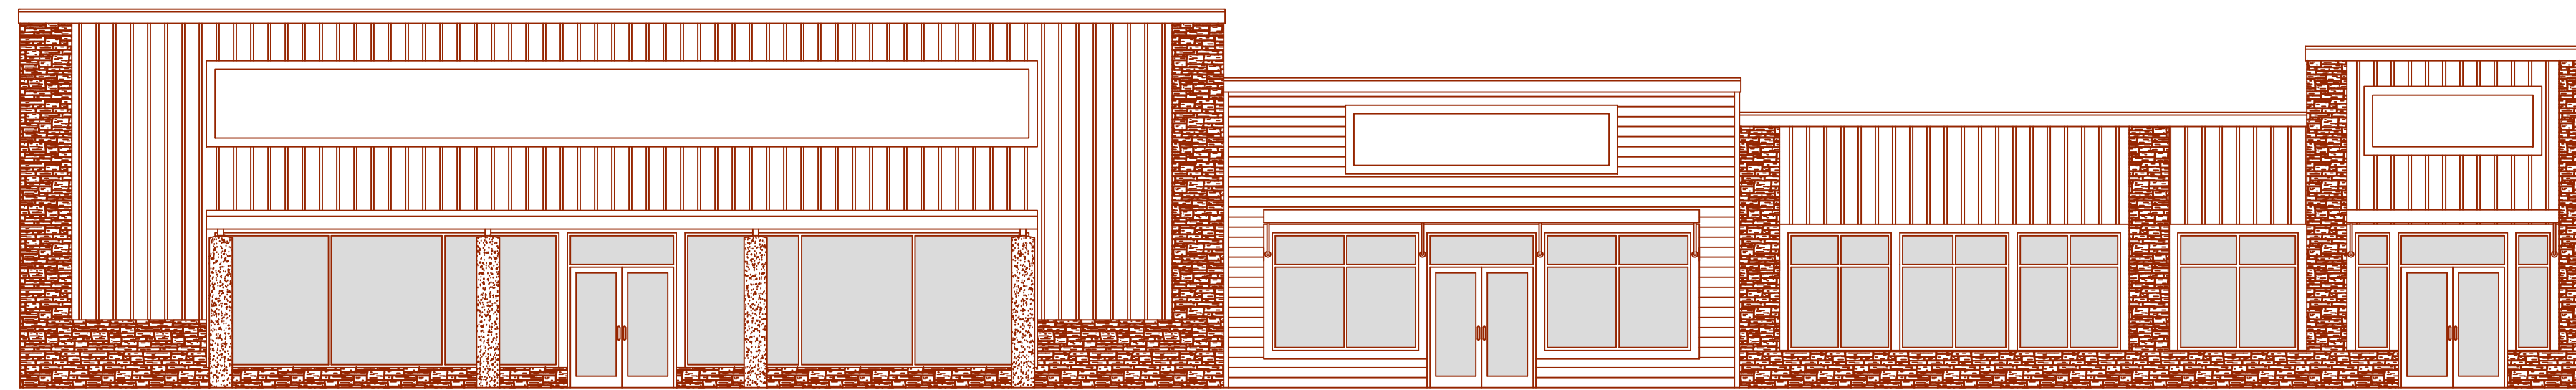

Front Elevation

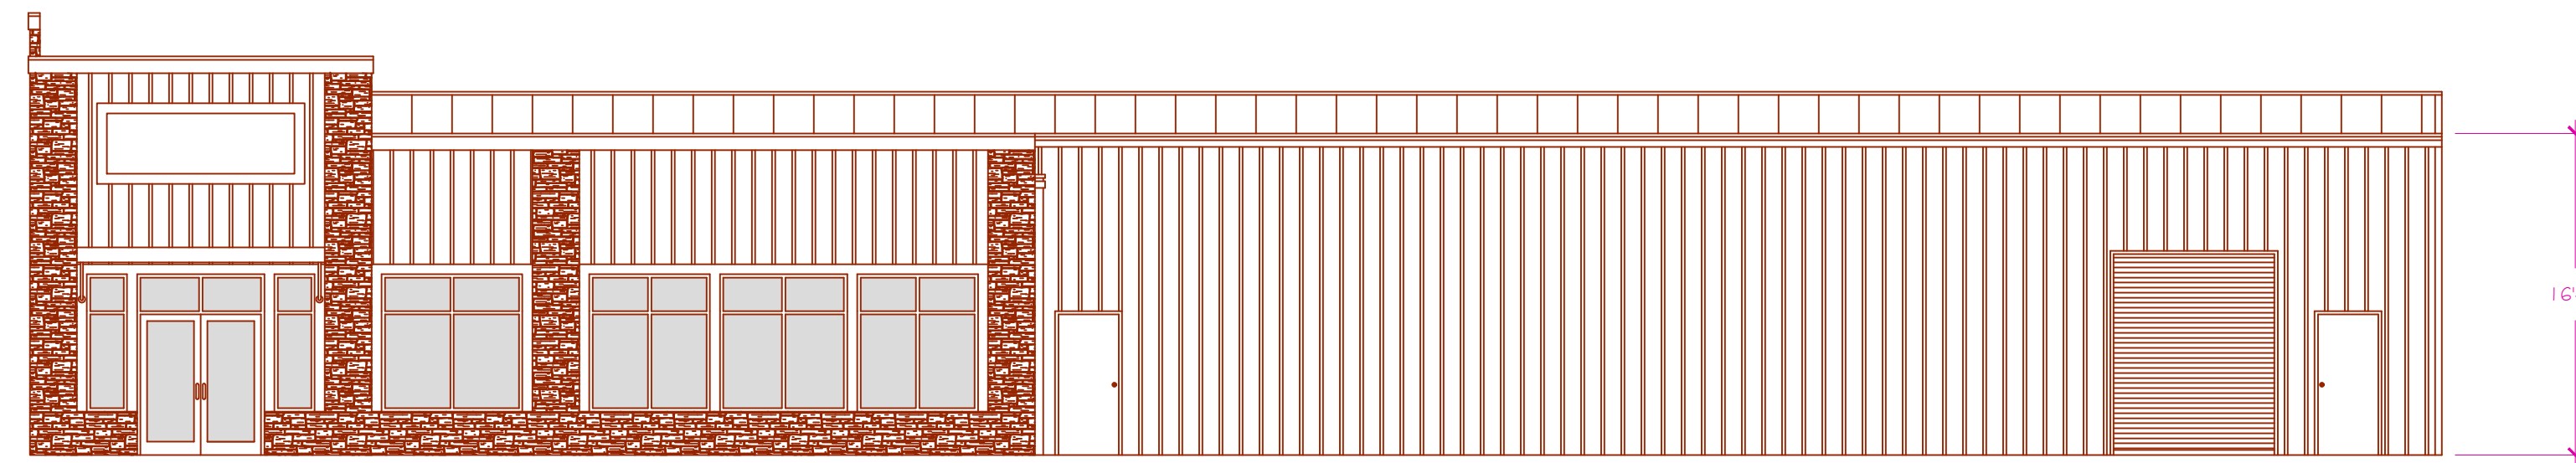

Right Side Elevation

General Notes

No.	Revision/Issue	Date

Firm Name and Address

423 Bowling Gap Circle
Blairsville, Georgia 30512
706-835-1458
www.winklerandwinkler.com

Project Name and Address

Sears Hometown Store
Blairsville, Georgia

Project	Sheet
Date	A5
Scale	

FNAME

REVDATE

USER